

ELECTRICAL PACKAGE - Job#3886824

NO.	TAG	PACKAGE #	LOCATION	SWITCHES		OPTION	FANS CONTROLLED				
				LOCATION	QUANTITY		TYPE	HP.	VOLTS	FLA.	
1		SC-321110MA-SEP	Wall Utility Cabinet Left	08 - Ship Loose w/ Presire	1 Light  1 Fan	Smart Controls Thermostatic Control w/ Relay On/Off with Supply	Exhaust	3	2,000	208V	5.9
							Exhaust	3	2,000	208V	5.9
							Supply	3	5,000	208V	15.0

JOB NO 3886824

MODEL NUMBER	SC-321110MA-SEP
--------------	-----------------

DRAWN BY

SCHEMATIC TYPE  
INSTALL








JOB NAME	Panda Express - Opelika AL (D...
----------	----------------------------------

DATE  
6/28/2019

DWG NO  
ECP #1-1

DESCRIPTION OF OPERATION:
---------------------------

3 Phase w/ control for 2 Exhaust Fans, 1 Supply Fan, Exhaust on in Fire, Lights out in Fire, Fan(s) On/Off  
Thermostatically Controlled. Separate Breaker Input for each Fan. Room temperature sensor shipped loose for field  
Installation. INVERTER DUTY 3 PHASE MOTOR REQUIRED FOR USE WITH VFD.

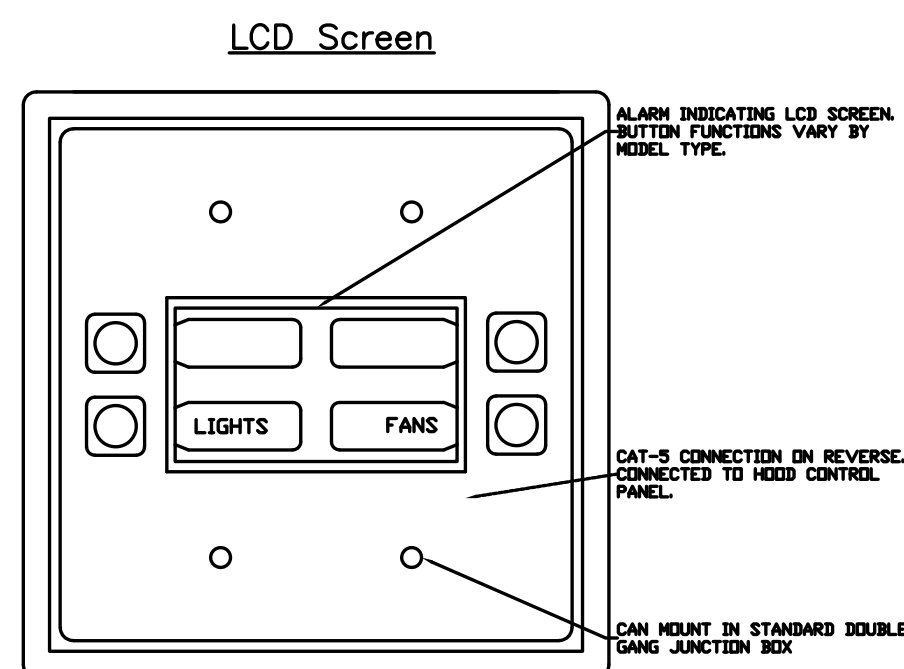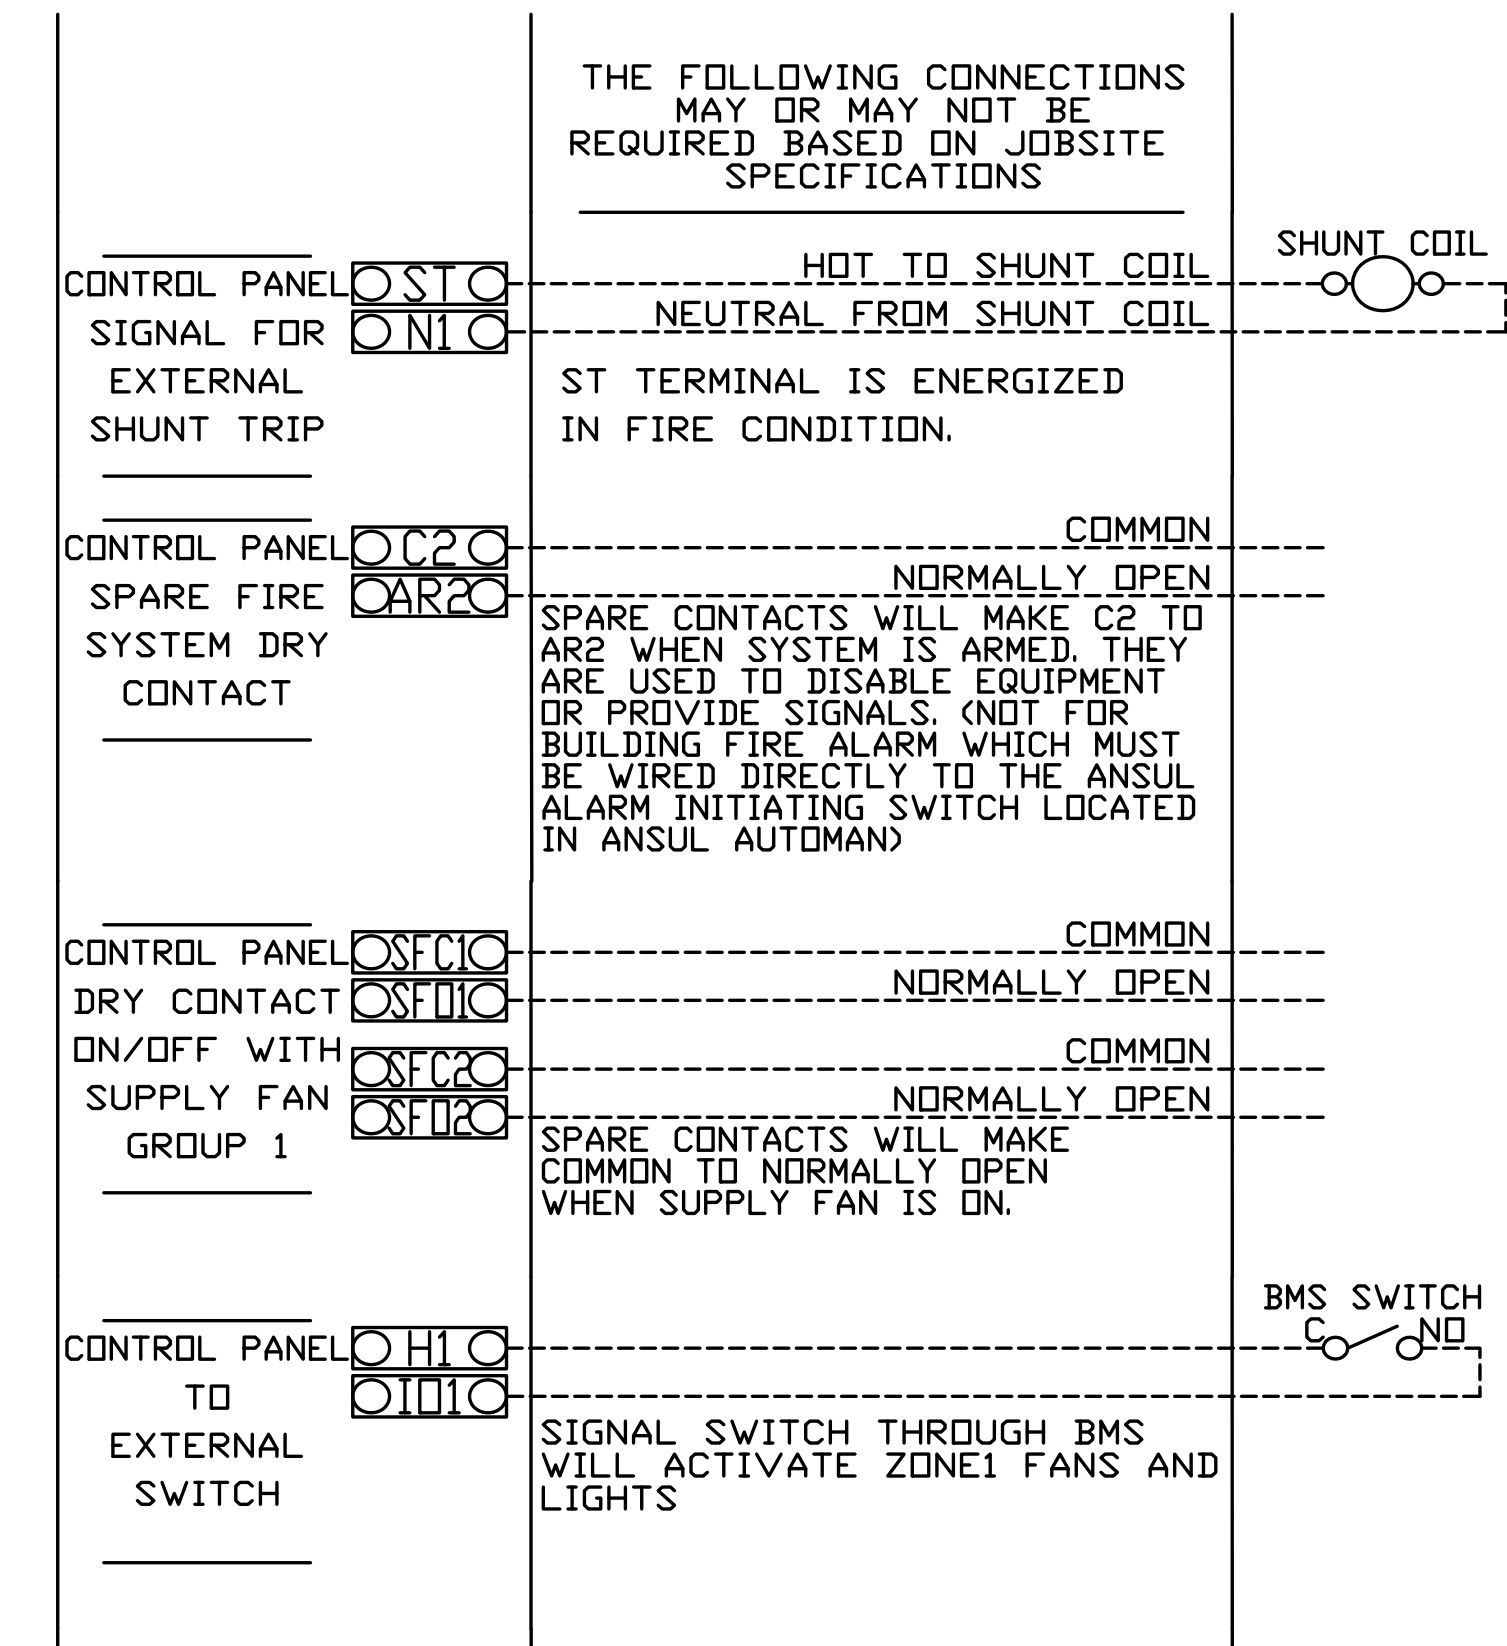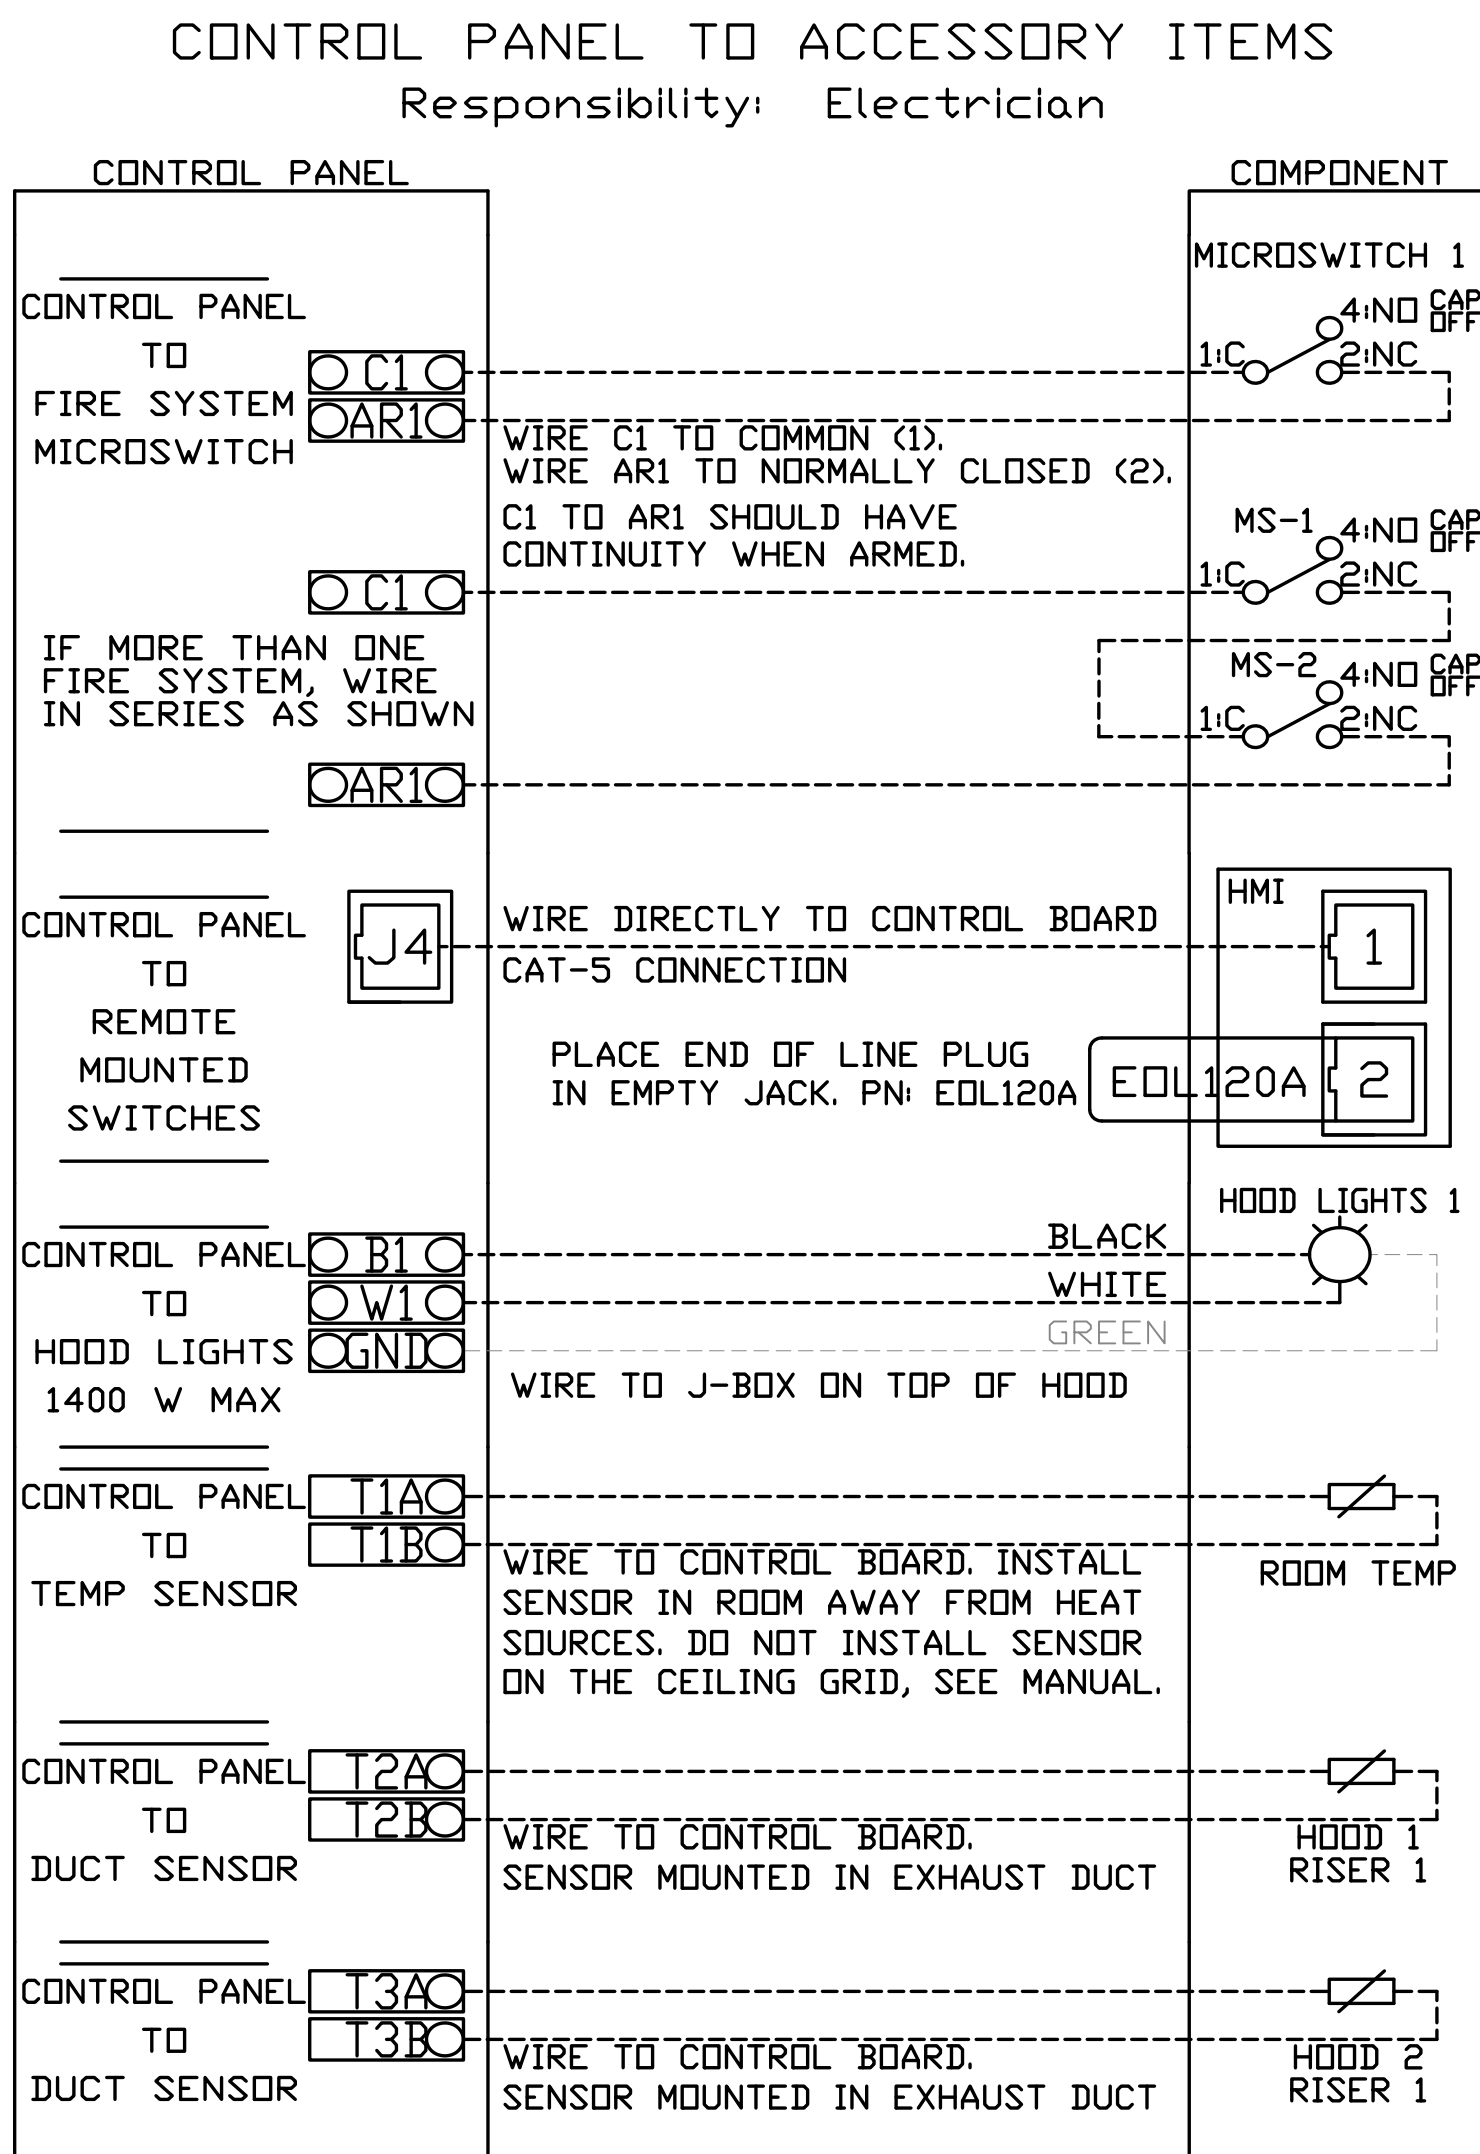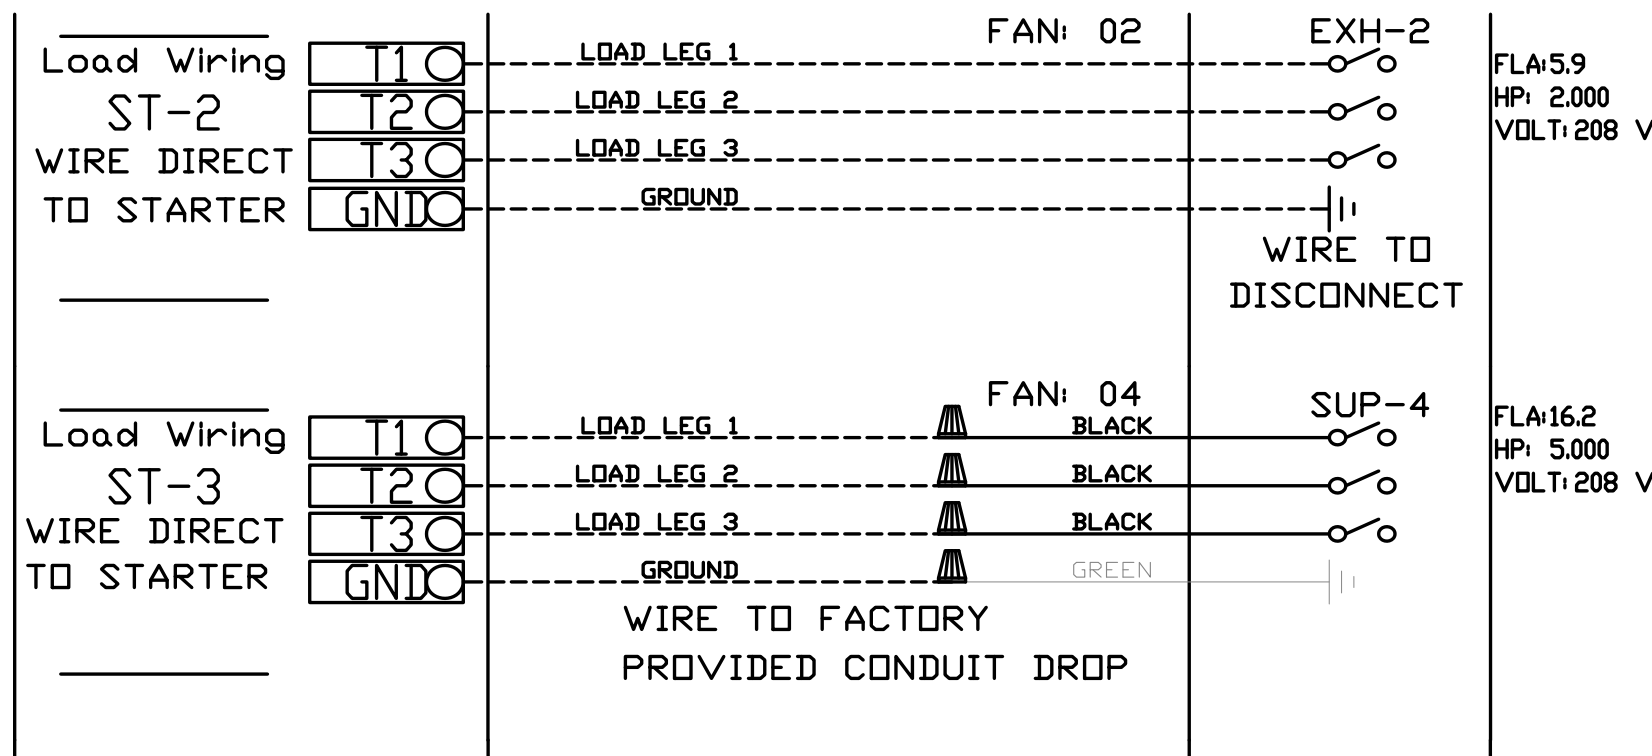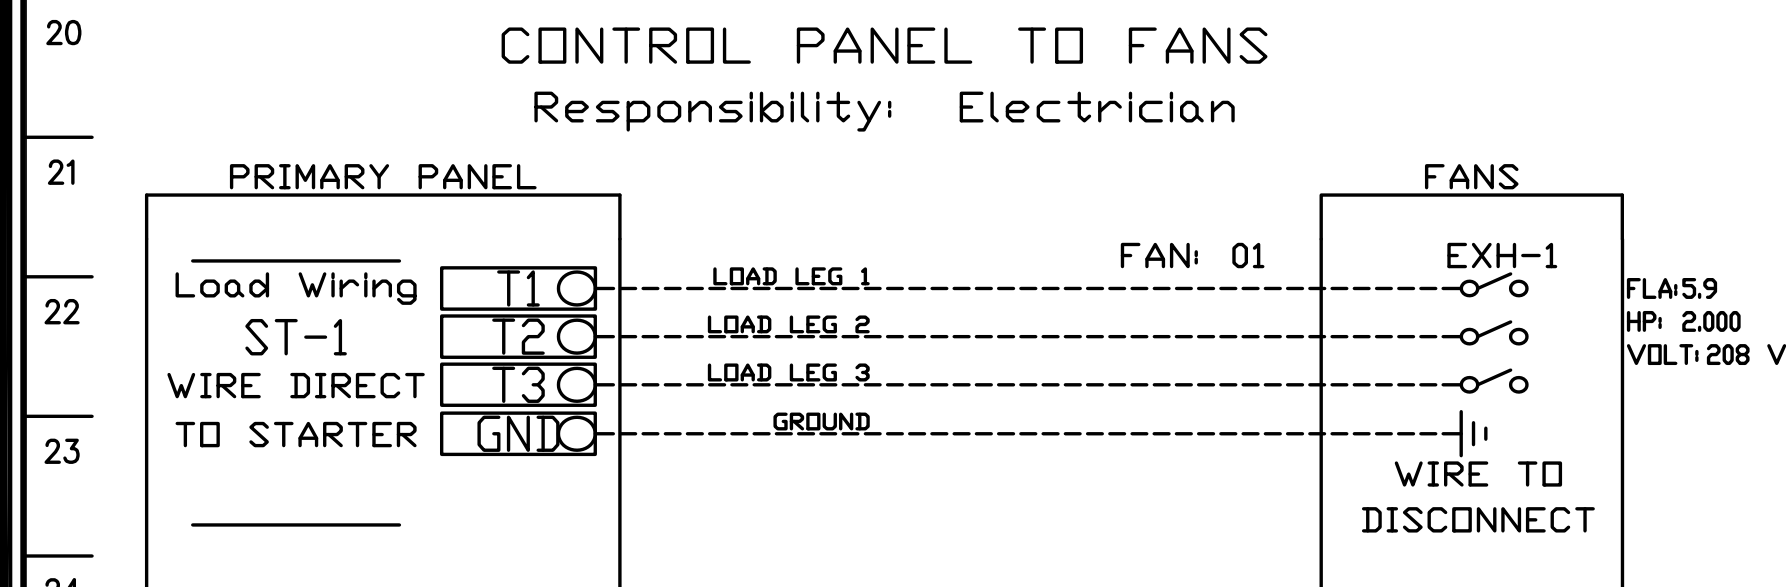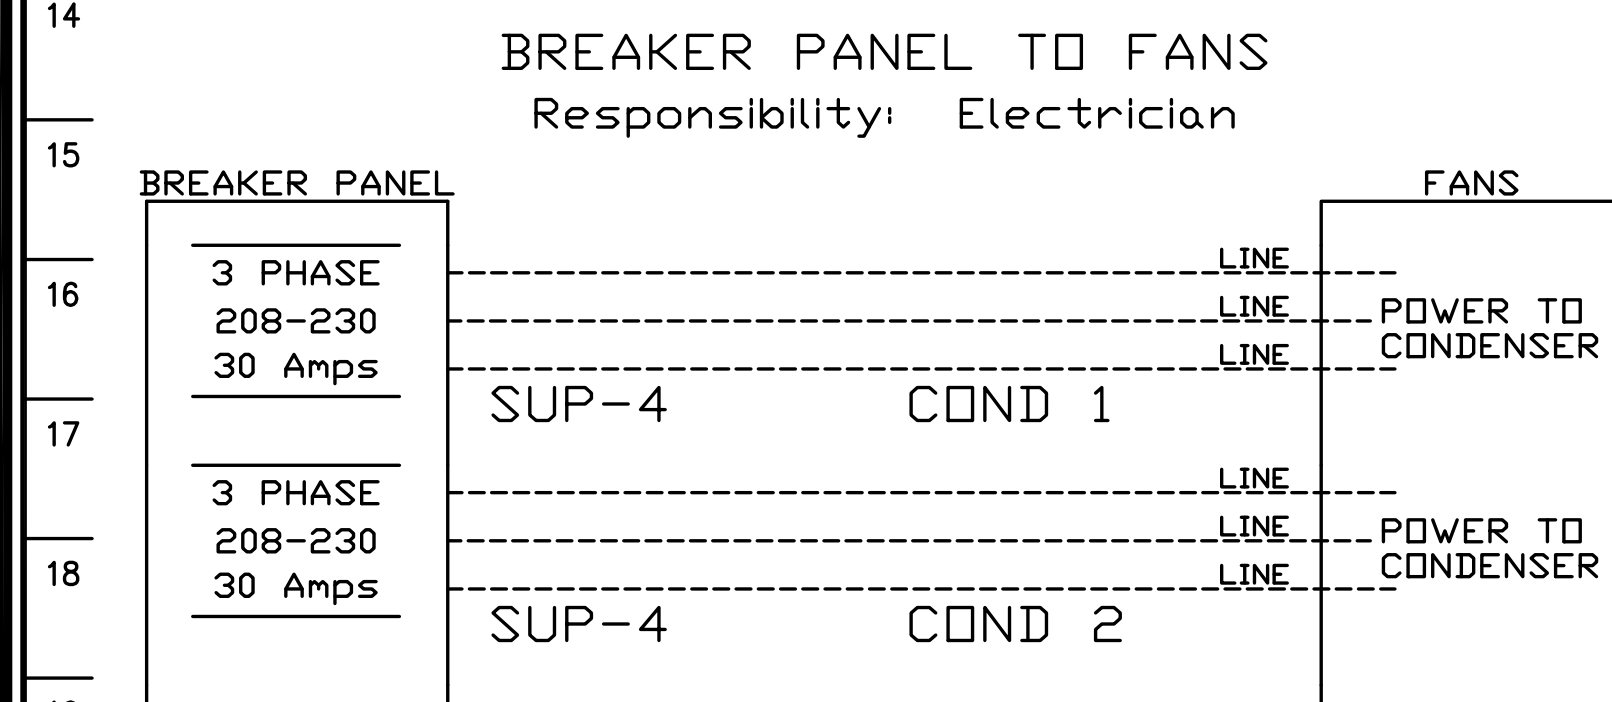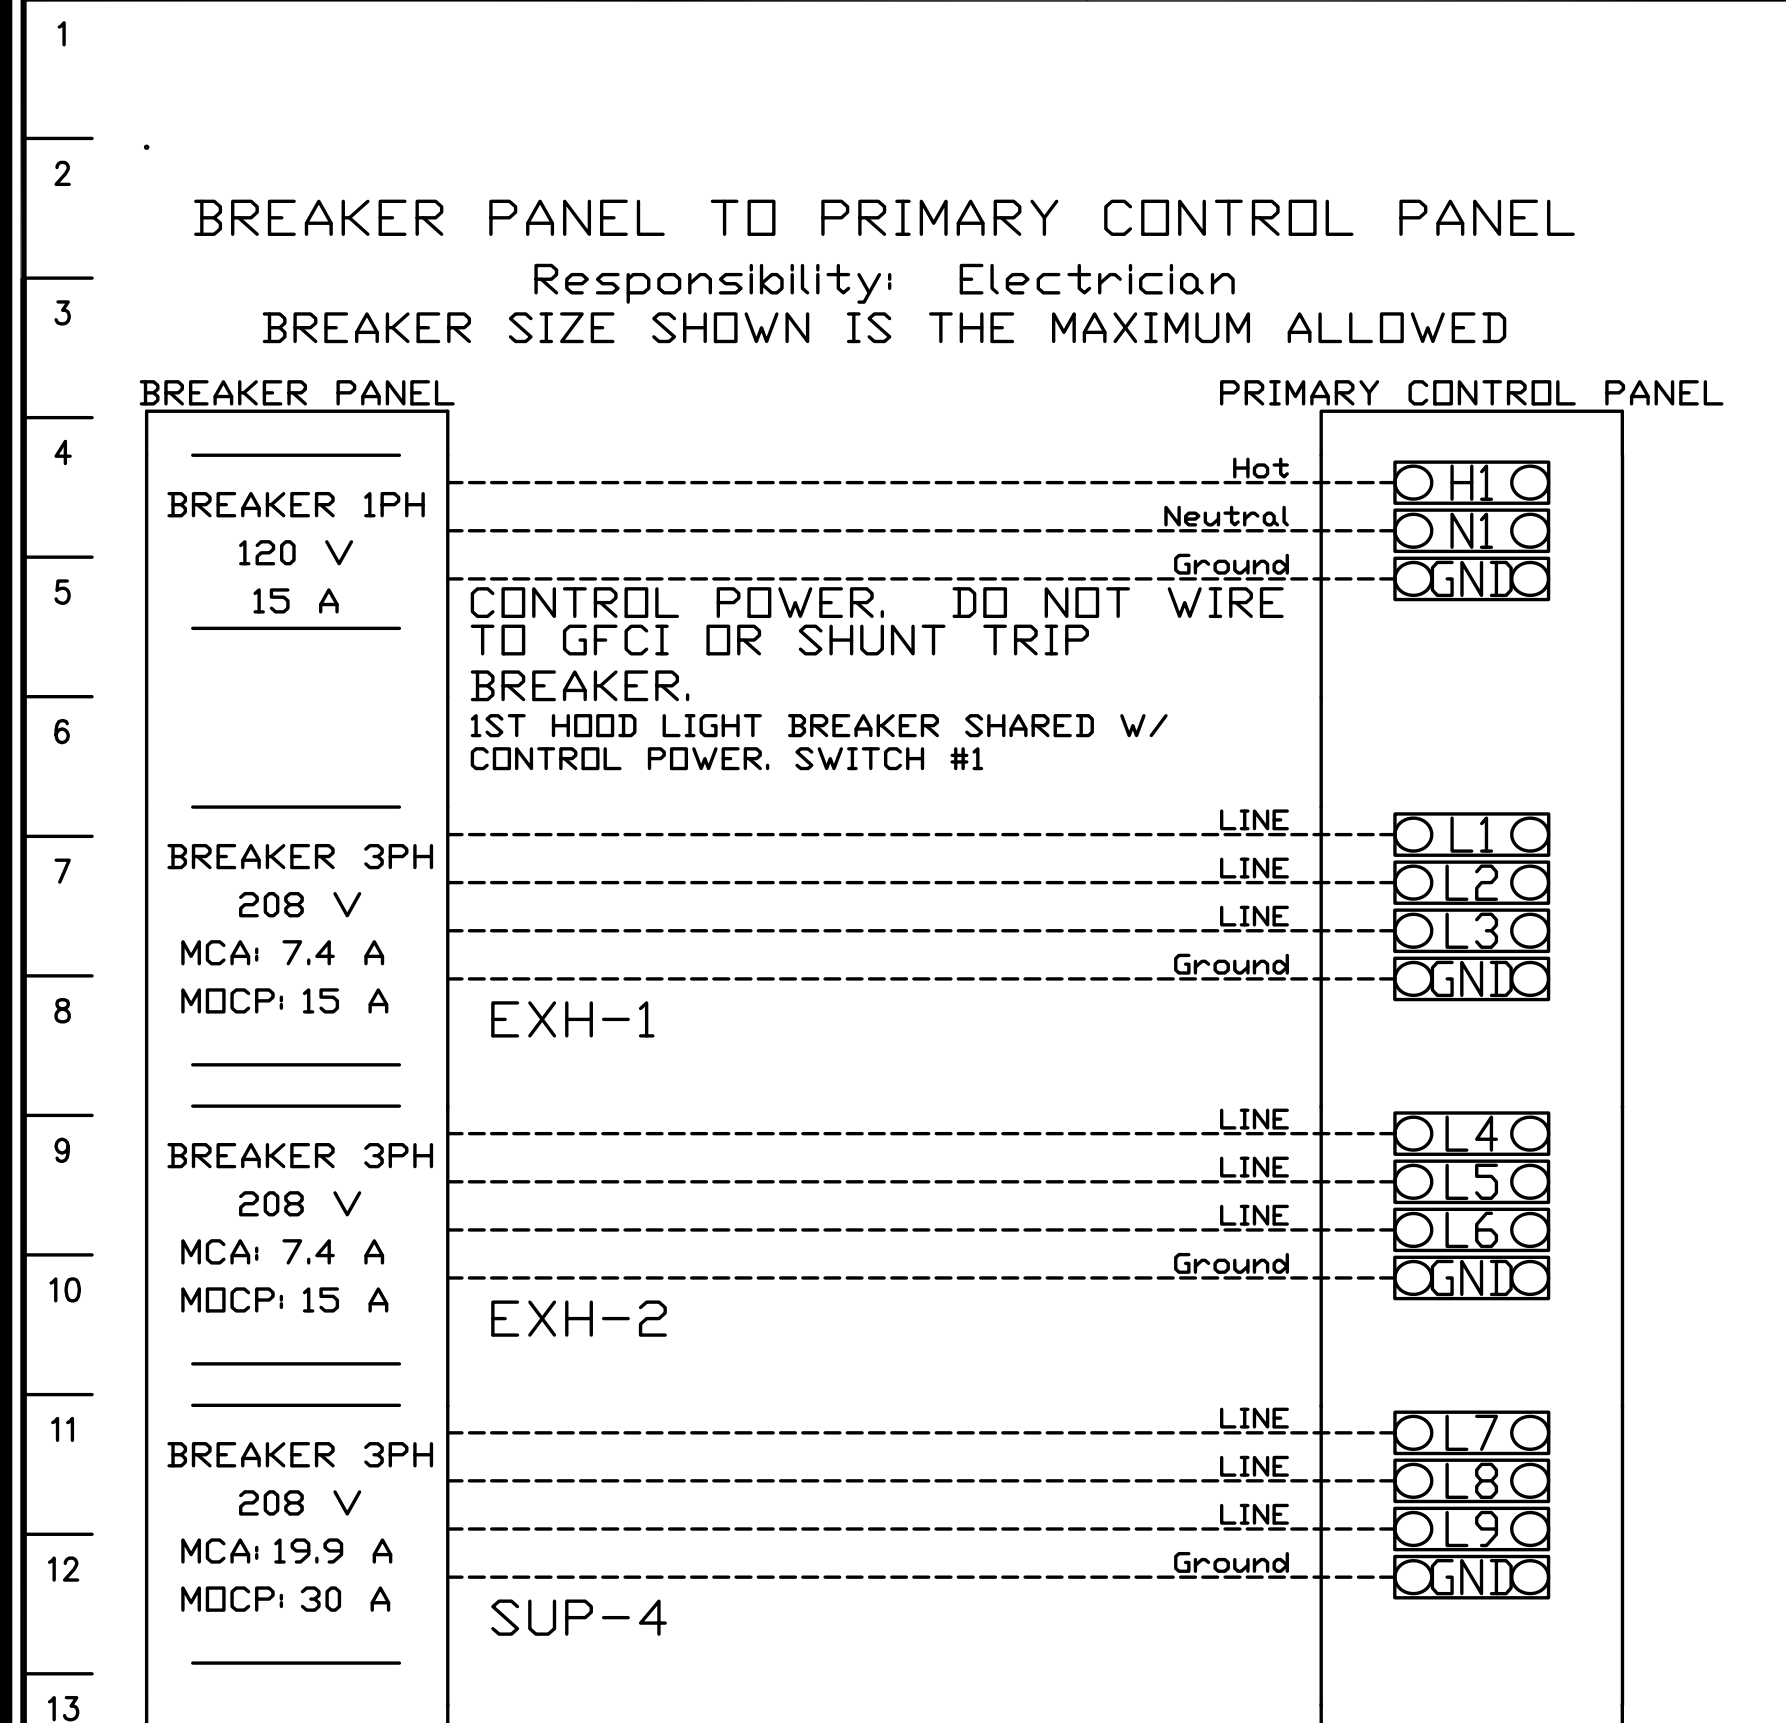



NOTE: UNLESS OTHERWISE STATED, PANDA RESTAURANT GROUP SHALL PROVIDE ALL EQUIPMENT ON THE FOLLOWING CAPTIVEAIRE SHEETS, INCLUDING: HOODS, FIRE SYTEM, EXHAUST FANS, SUPPLY FAN, BATHROOM FAN AND ELECTRICAL INTERLOCK PACKAGE

ANSUL GAS VALVE:

THE ANSUL GAS VALVE IS PROVIDED BY CAPTIVEAIRE SYSTEMS. CONTACT OUR OFFICE WITH THE VALVE SIZE 3 DAYS IN ADVANCE OF WHEN IT IS NEEDED ON SITE.

FOR QUESTIONS CALL THE  
CAPTIVEAIRE  
SOUTHERN CALIFORNIA OFFICE  
STONE MILL DESIGN CENTER  
2915 RED HILL AVE, SUITE C106  
COSTA MESA, CA 92626  
TEL: 800-967-7701 EMAIL: REG86@CAPTIVEAIRE.COM

REVISIONS		
	DESCRIPTION	DATE:
△		
△		
△		
△		

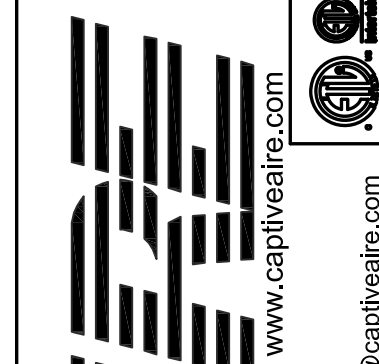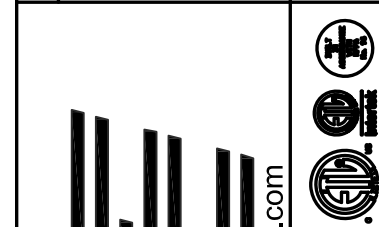

**Southern California Office**

**PANDA EXPRESS, INC.**  
1683 Walnut Grove Ave.  
Rosemead, California  
91770  
Telephone: 626.799.9898  
Facsimile: 626.372.8288

All ideas, designs, arrangement and plans indicated or represented by this drawing are the property of Panda Express Inc. and were created for use on this specific project. None of these ideas, designs, arrangements or plans may be used by or disclosed to any person, firm, or corporation without the written permission of Panda Express Inc.

REVISIONS:



ISSUE DATE:

1st	DEVELOPER REVIEW	07.15.19
2nd	SITE PLAN SUBMITTAL	08.26.19
3rd	SITE COMMENTS	09.05.19
4th	ISSUE FOR PERMIT	10.01.19
5th	ISSUE FOR BID	11.07.19

DRAWN BY: PM / KL / EA

PANDA PROJECT #: S8-20-D7163

ARCH PROJECT #: 19027

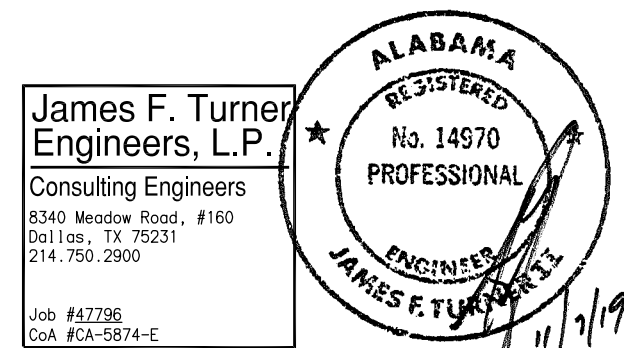

**Heights Venture**  
ARCHITECTURE • DESIGN  
FOR INFORMATION ONLY

HOUSTON	DALLAS
1111 North Loop West, Suite 800	5741 Legacy Drive, Suite 320
Houston, Texas 77008	Plano, Texas. 75024
713 869 1103 V	972 490 7292 V

## PANDA EXPRESS

2096 INTERSTATE DR  
OPELIKA, AL, 36801

3600 FSDT

TWW REMODE

TWW REMODE

*(continued)*

**SHEET NO.**  
5

# M-404

HOOD DETAIL PLAN

TRUE WARM & WELCOME

# BID ISSUE